


V-100
 3-PHASE SEPARATOR
 INTERNAL: 1440 PSIG @ 120°F
 EXTERNAL: N/A @ N/A
 42" I.D. X 15'-0" S/S
 ASME SECTION VIII, DIV 1
 C.A.: 1/8"
 N.D.E. TESTING: RT-1

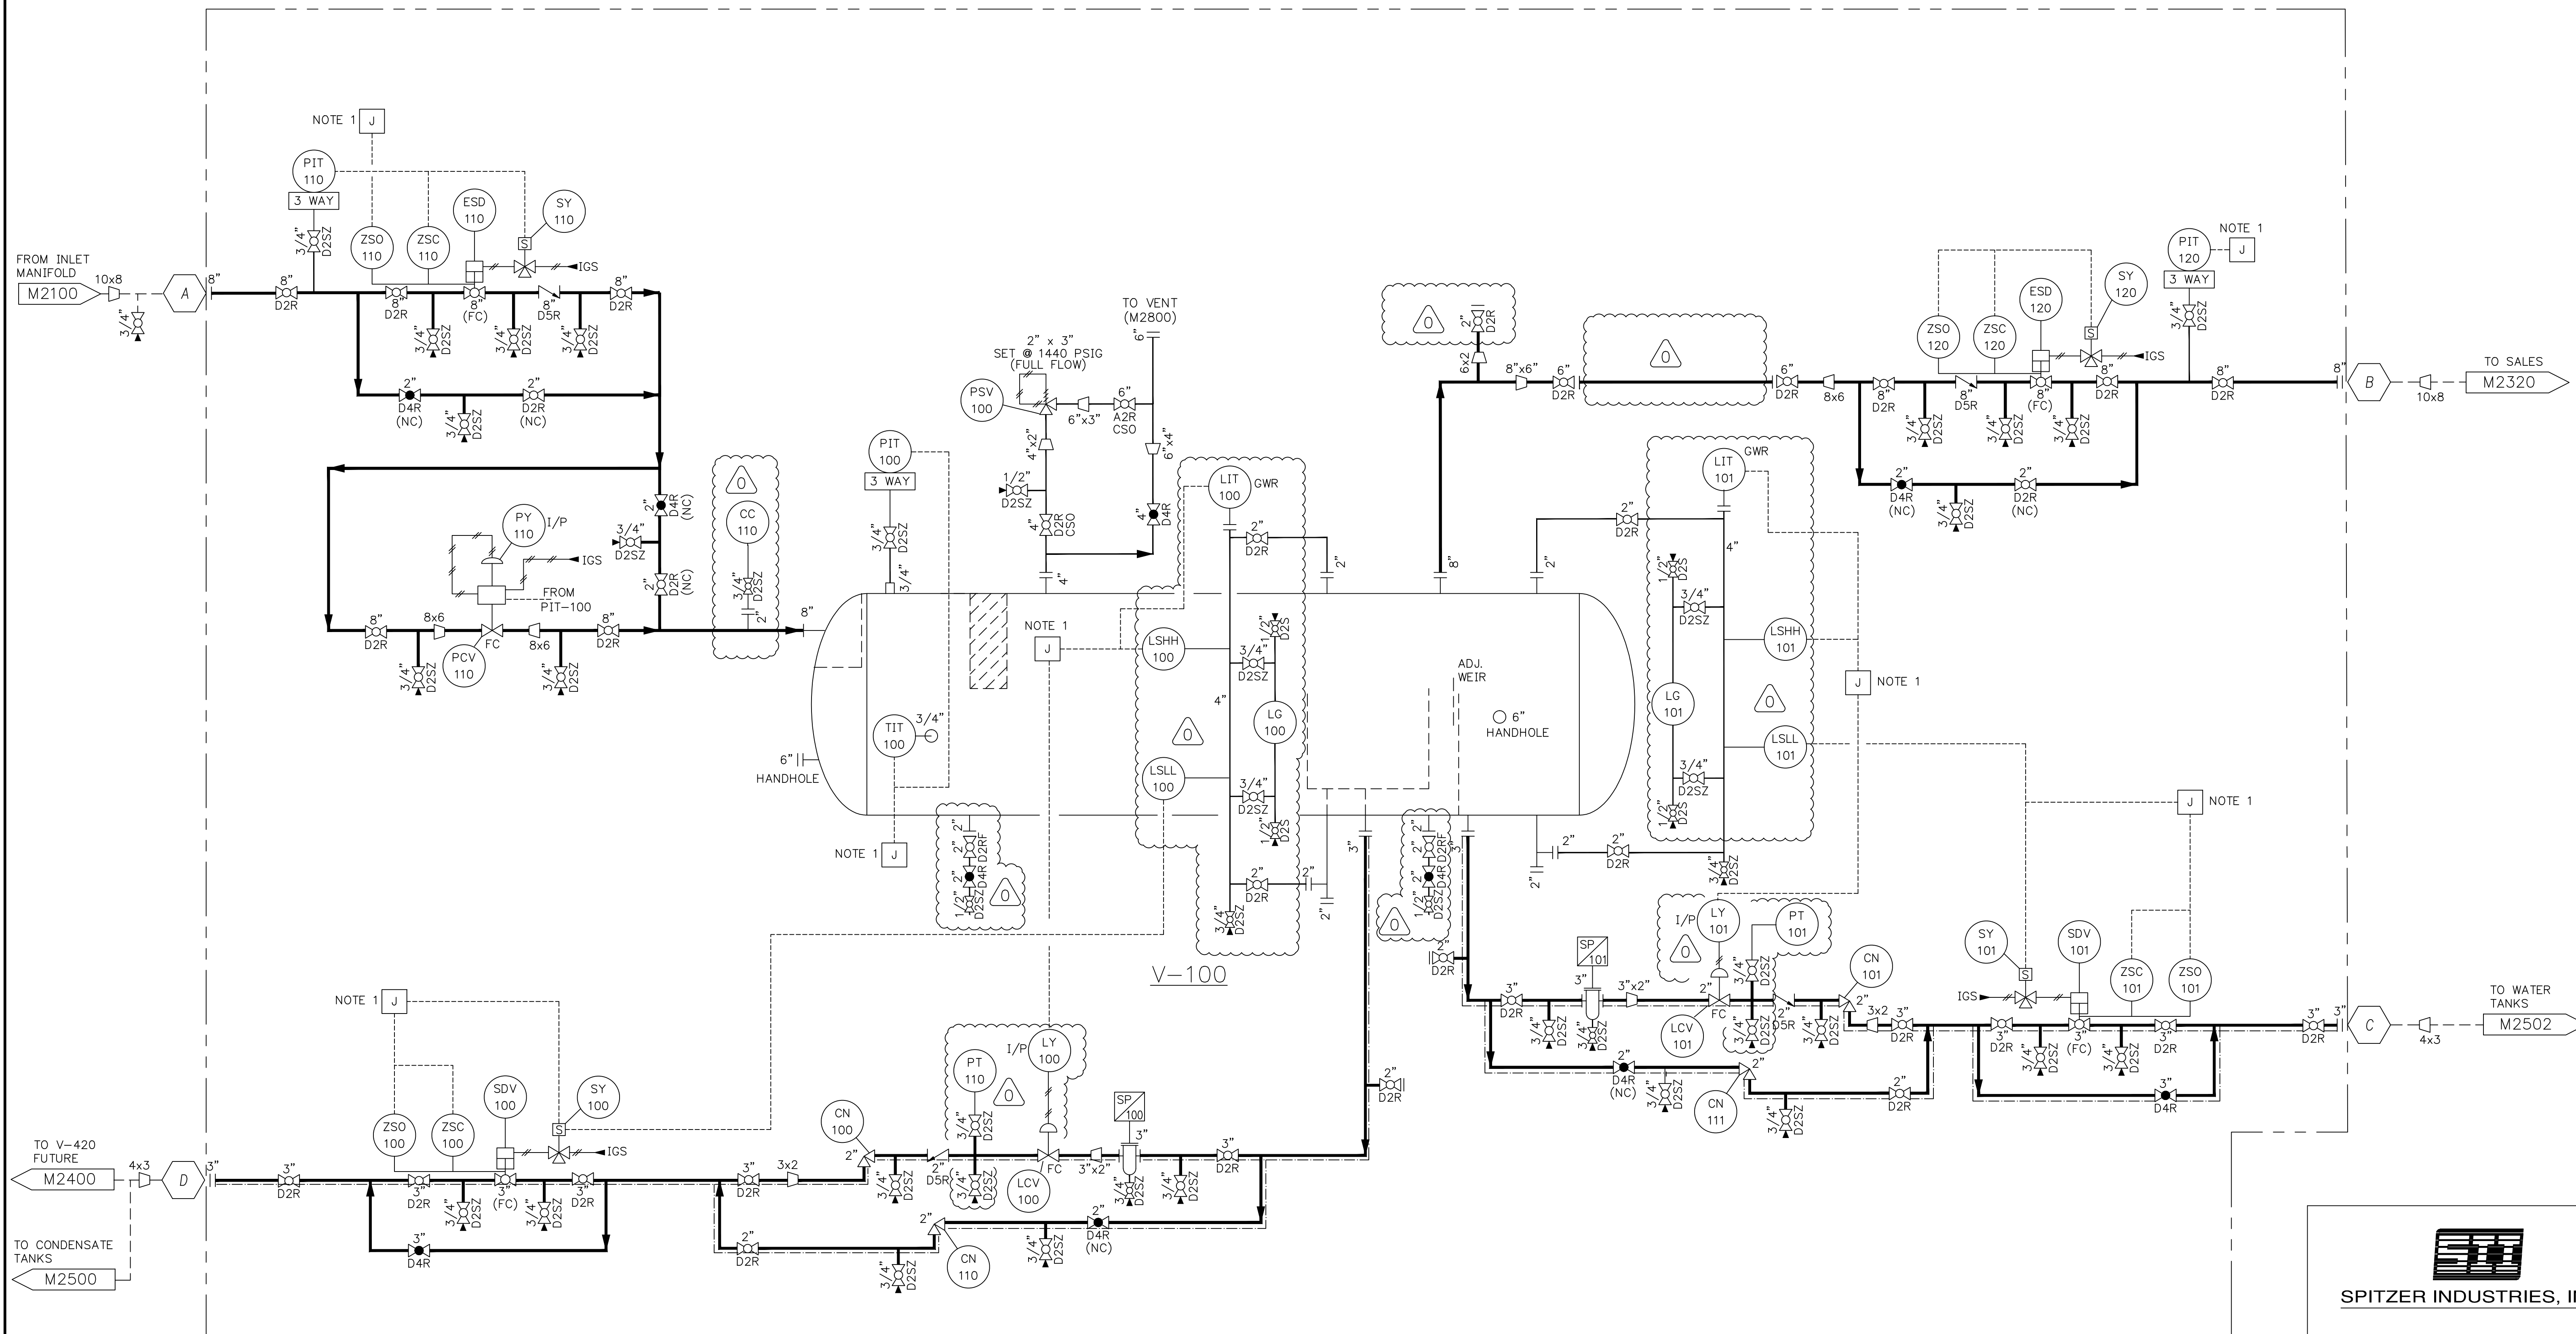

NOTES:
 1. ALL ALARMS AND INDICATORS ELECTRIC TO A SINGLE JUNCTION BOX ON SKID.
 2. OMITTED
 3. ANADARKO STD SIMPLEX METER RUN.
 4. ALL CONTROLS AND SHUTDOWNS PNEUMATIC WITH ON SKID PANEL.



PROJECT		ANADARKO / AUDUBON	
P.O. NUMBER:	ITEM NO.	V-100	
TITLE 3-PHASE HORIZONTAL SEPARATOR P & ID			
DRAWN	DATE	CHECKED	DATE
MLR	12/3/13	DB	12/3/13
JOB NO.	SHEET NO.	DRAWING NO.	REV
J4852-101	1 OF 1	J4852-101-1	0

NO	REVISION	DATE	BY	CK
1	ISSUED FOR CONSTRUCTION	2/10/14	MAK	DB
2	ISSUED FOR APPROVAL	12/3/13	MLR	DB